


STANDARD 8' x 18' DOUBLE AXLE FOOD TRAILER

For custom plans, please contact Heekin Architectural LLC
 ray.heekin@gmail.com / (617) 642-6178

American Food Trailers

AmericanFoodTrailers.com

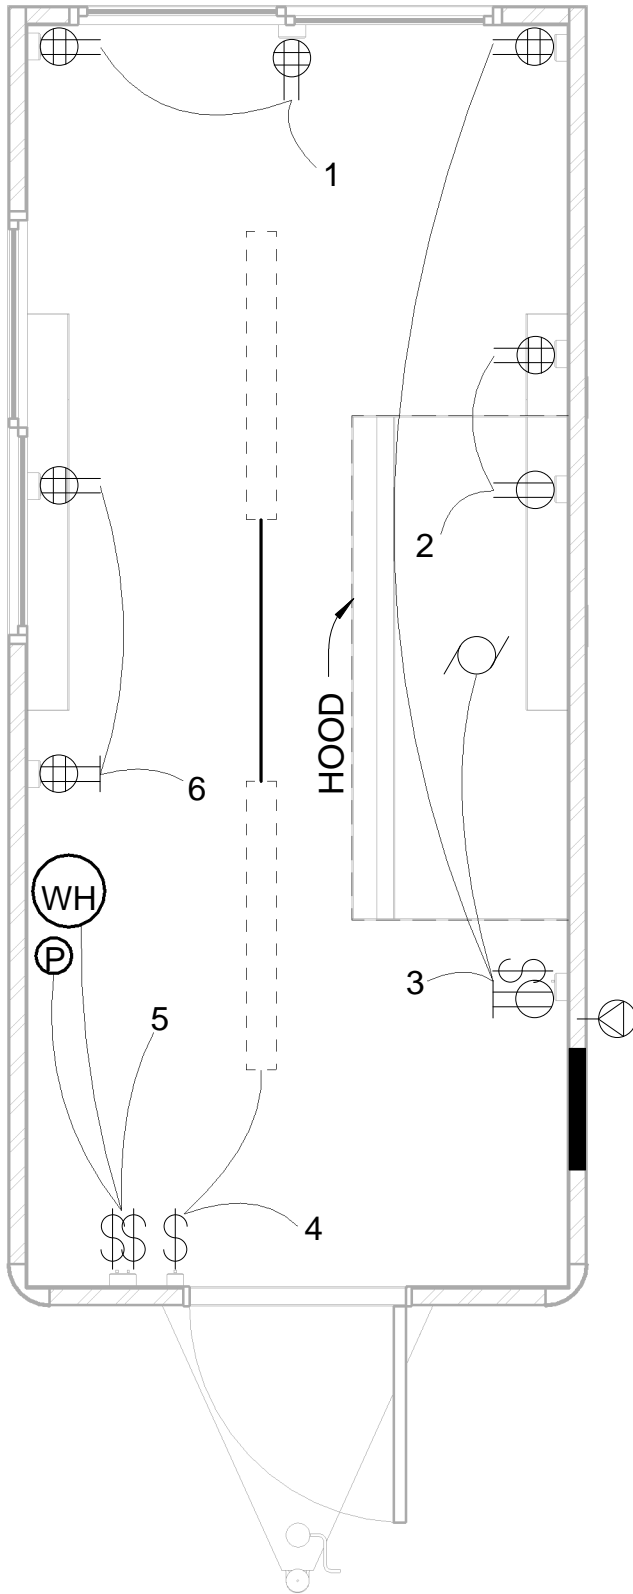


ELECTRICAL LEGEND	
	QUADRUPLEX GFI OUTLET
	QUADRUPLEX OUTLET
	DUPLEX GFI OUTLET
	DUPLEX OUTLET
	50A INLET
	SWITCH
	125A PANEL
WH	WATER HEATER
	WATER PUMP
	FAN
	FLUORESCENT LIGHT
	12 GAGE RIGID METAL CONDUIT MOUNTED TO INSIDE FACE OF TRAILER WALL
1	CIRCUIT SPACE NUMBER

ELECTRICAL FLOOR PLAN
STANDARD 8' x 18' DOUBLE AXLE FOOD TRAILER
 SCALE: 3/8" = 1' - 0"

For custom plans, please contact Heekin Architectural LLC
 ray.heekin@gmail.com / (617) 642-6178

American Food Trailers

AmericanFoodTrailers.com

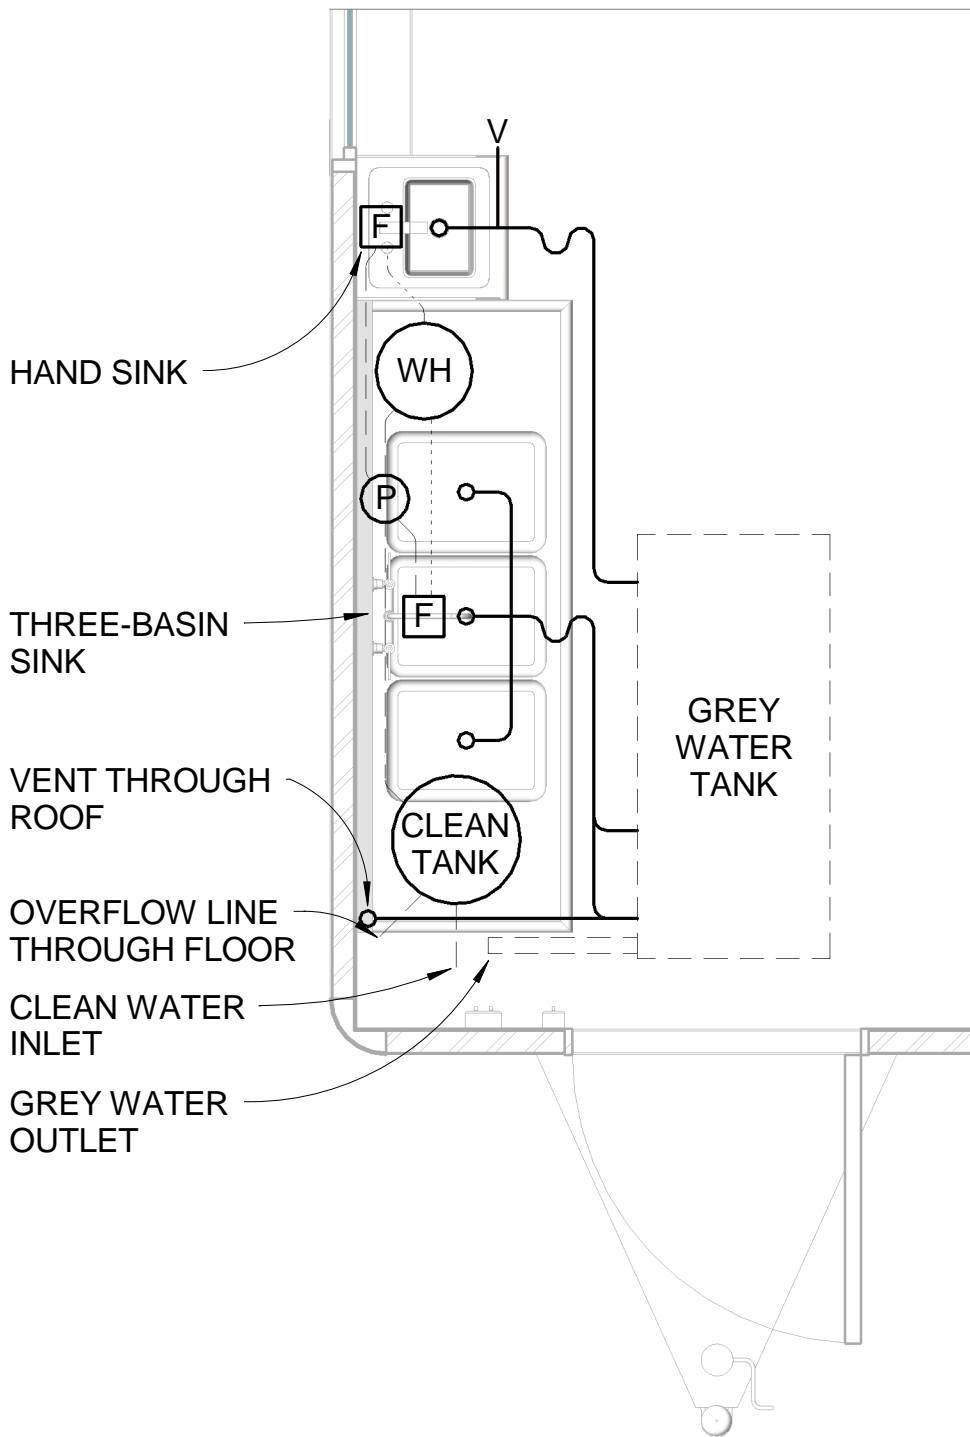

HAND SINK

THREE-BASIN SINK

VENT THROUGH ROOF

OVERFLOW LINE THROUGH FLOOR

CLEAN WATER INLET

GREY WATER OUTLET

GREY WATER TANK

PLUMBING LEGEND	
Ⓟ	WATER PUMP
WH	WATER HEATER
ⓕ	FAUCET
V	ABS IN-LINE VENT
---	COLD WATER
----	HOT WATER
—	GREY WATER

ALL POTABLE WATER LINES ARE 3/4" BRAIDED RUBBER HOISING

GREY WATER LINES ARE 2" PVC

GREY WATER DRAIN PIPE IS 2" PVC

DISTANCE FROM WATER PUMP TO FURTHEST PLUMBING FIXTURE: 2' - 0"

PLUMBING FLOOR PLAN
STANDARD 8' x 18' DOUBLE AXLE FOOD TRAILER
 SCALE: 1/2" = 1' - 0"

For custom plans, please contact Heekin Architectural LLC
 ray.heekin@gmail.com / (617) 642-6178

American Food Trailers

AmericanFoodTrailers.com